


Figured dimensions only are to be used.
Contractor must verify all dimensions on site before commencing work. Any discrepancies must be brought to the attention of the architect.

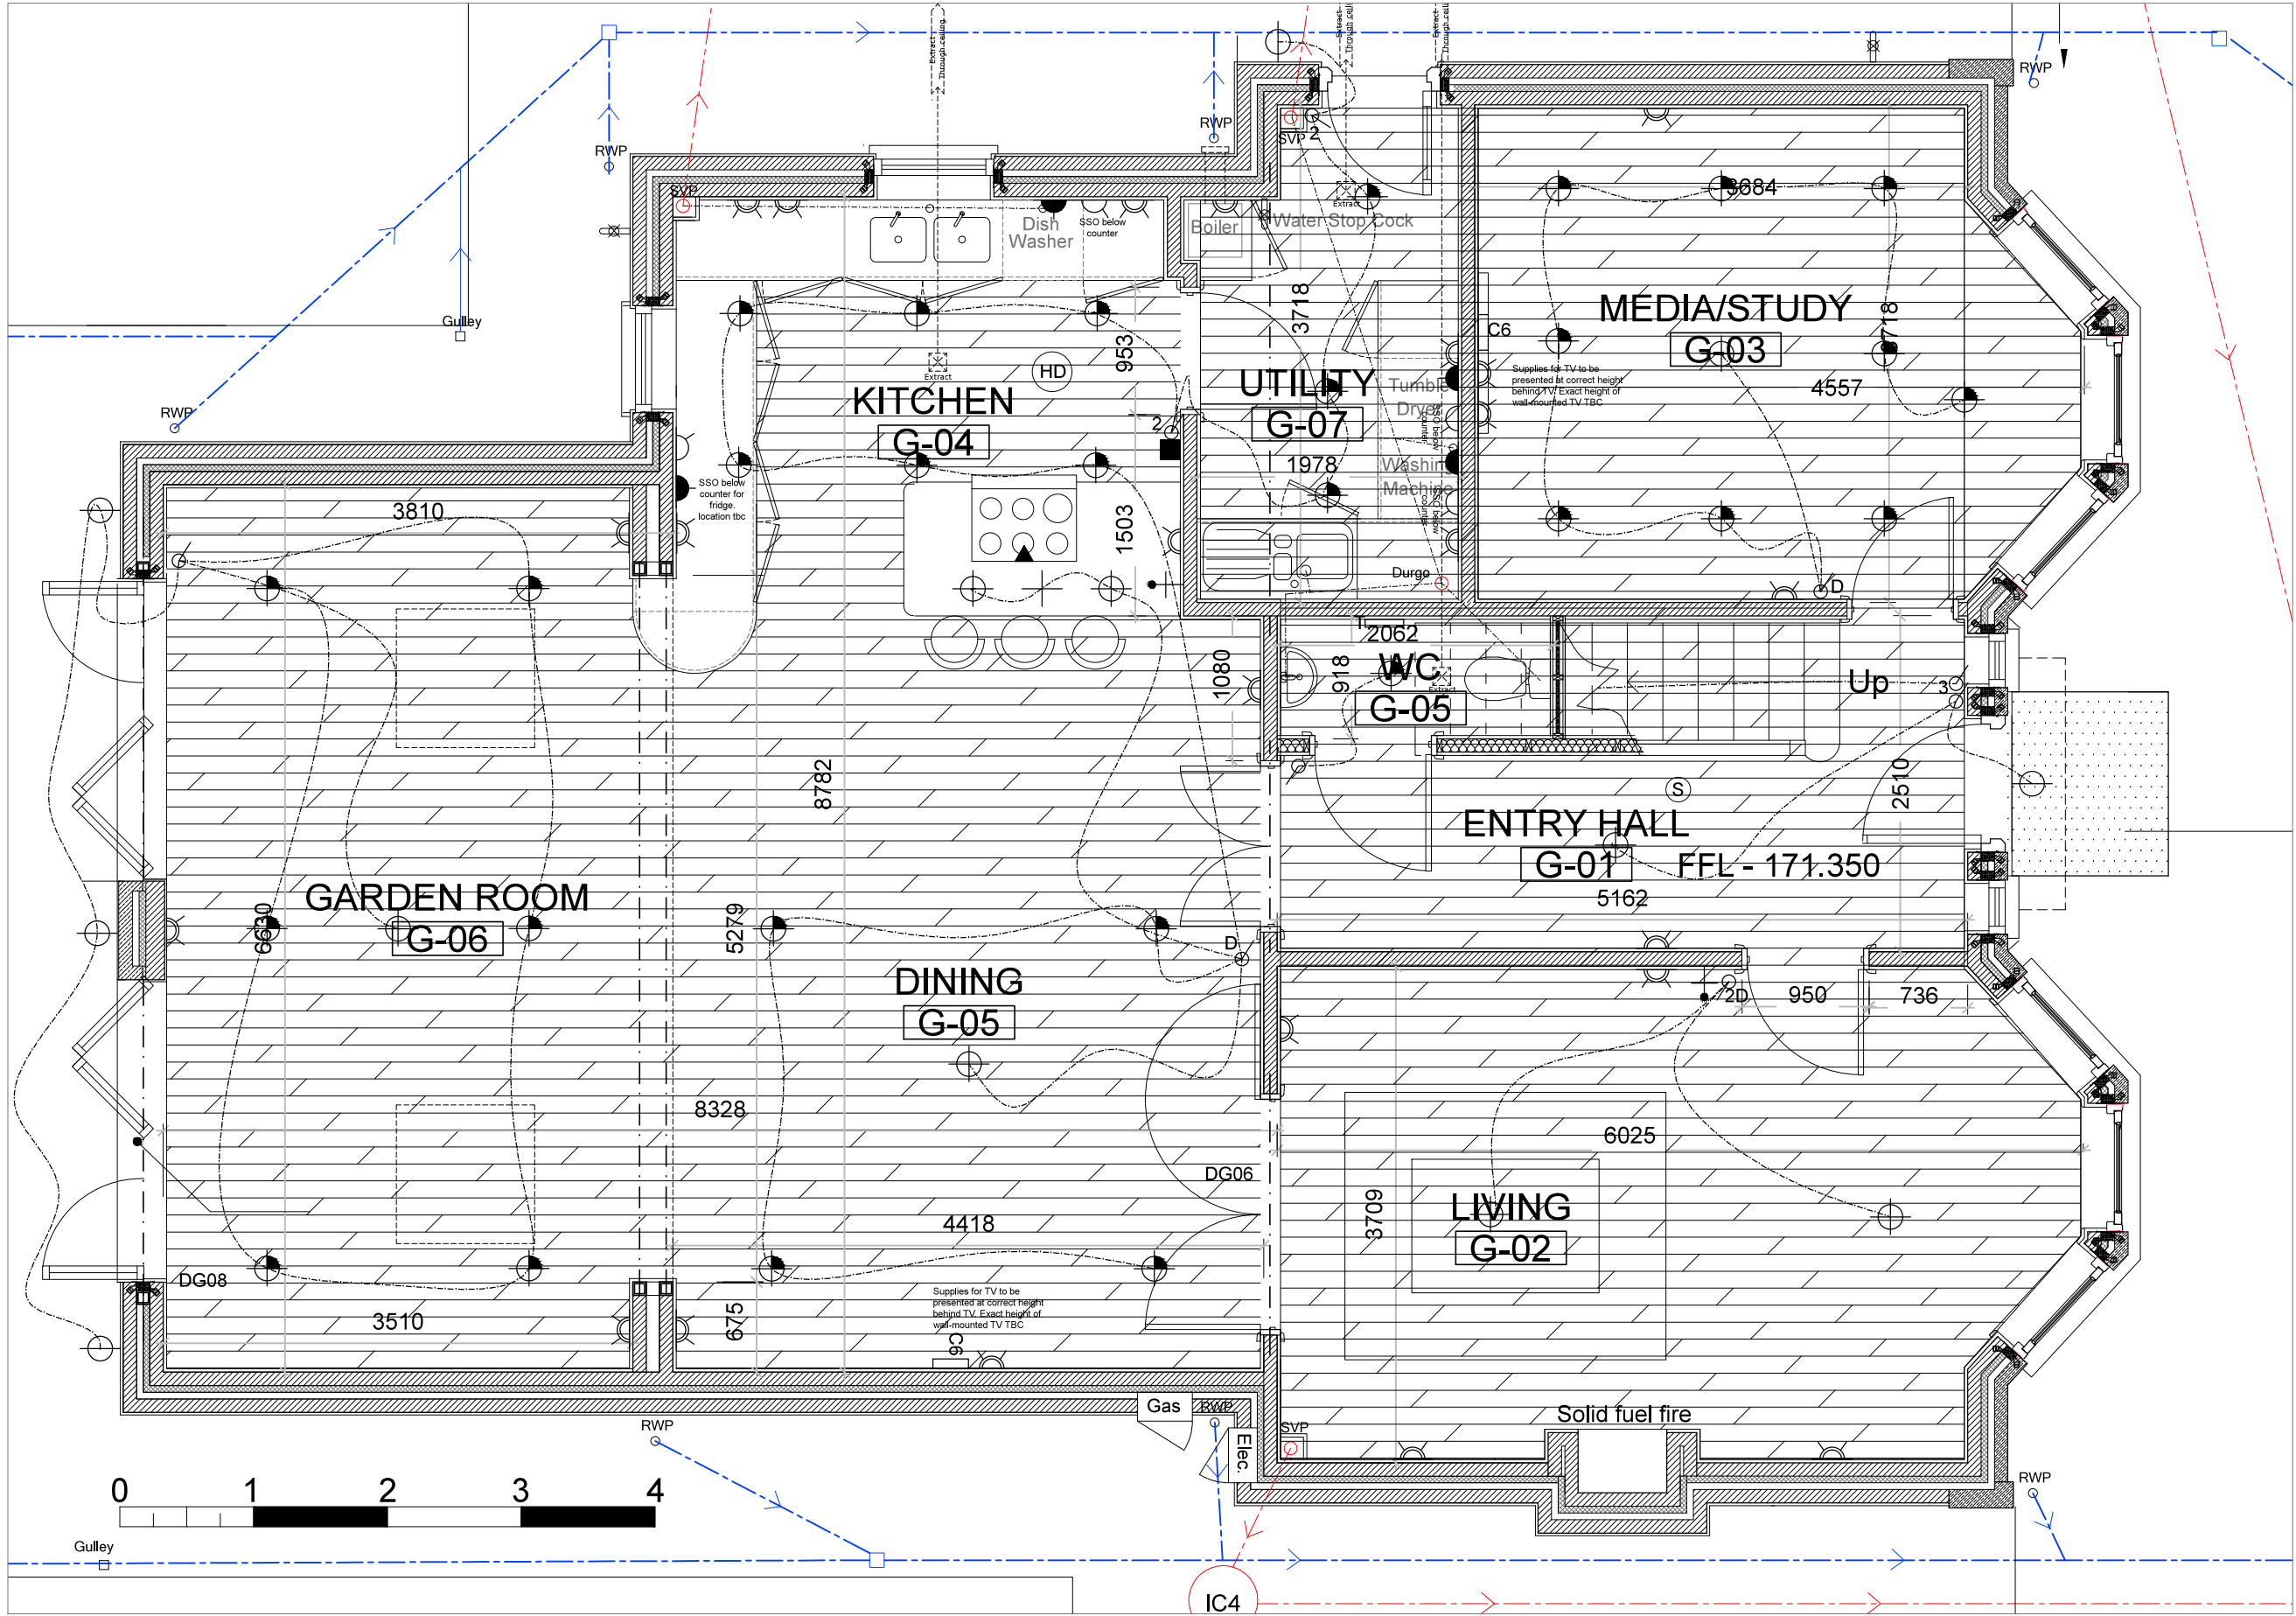

- Ⓢ Interlinked smoke activated smoke alarm to BS5839 & BS5446
- Ⓜ Interlinked heat activated smoke alarm to BS5839 & BS5446
- ⊙ External light
- Enclosed bulb light
- ⊕ Ceiling light pendant
- ⊕ Recessed LED Downlighter. NB all lighting fitting in damp/wet areas to be IP65 rated. 'G' denotes Gimble fitting required
- ⚡ 13A Single Switched Socket Outlet
- ⚡ 13A Twin Switched Socket Outlet
- ⚡ Unswitched fused spur
- ⚡ Switched fused spur
- ⚡ 20A One Way Light Switch (D indicates dimmer)
- ⚡ 20A Two Way Light Switch
- ⚡ Gas Point
- ⚡ Telephone Point
- ⚡ Mechanical Extractor Fan
- SS Electric Shaver Socket
- Electric Towel Rail
- M Illuminated Mirror Cabinet
- C6 CAT 6 Network Socket
- TV Point
- Underfloor Heating Controls
- Underfloor Heating
- 12mm Ply pattress to run from floor level to +1800mm behind hardbacker board

PRELIMINARY

CLEAR FUTURE
ARCHITECTURE

1A Trymwood Parade, Stoke Bishop, Bristol. BS9 2DP
T: 01179 621432 E: mark.watkins@cf-architecture.co.uk

© 2013

Client

Land&Buildings (Lansdown Ltd)

Project

WALPOLE, CHARLCOMBE
LANE, BATH. BA1 5TP

Drawing Title

PROPOSED GROUND FLOOR
ELECTRICAL LAYOUT

Drawing Number

1067-060

Rev.

-

Date

Mar 2015

Scale

1:50@A1, 1:100@A3

Drawn

hw

Ground Floor